

NEW CONSTRUCTION
OF
MULTI-AGENCY CENTER
FOR
CAMDEN COUNTY

BROADWAY AND LIBERTY STREET
CAMDEN, NEW JERSEY




20 N. Doughty Avenue
Somerville, NJ 08876
t 908.722.2300
f 908.722.7201

usaarchitects.com

Paul R. Swartz, AIA
Armand T. Christopher Jr., AIA
Peter C. Campisano, AIA
Susan M. DeHart, AIA
James McAuffrey, AIA
Eric DeLong, AIA

PROJECT LOCATION

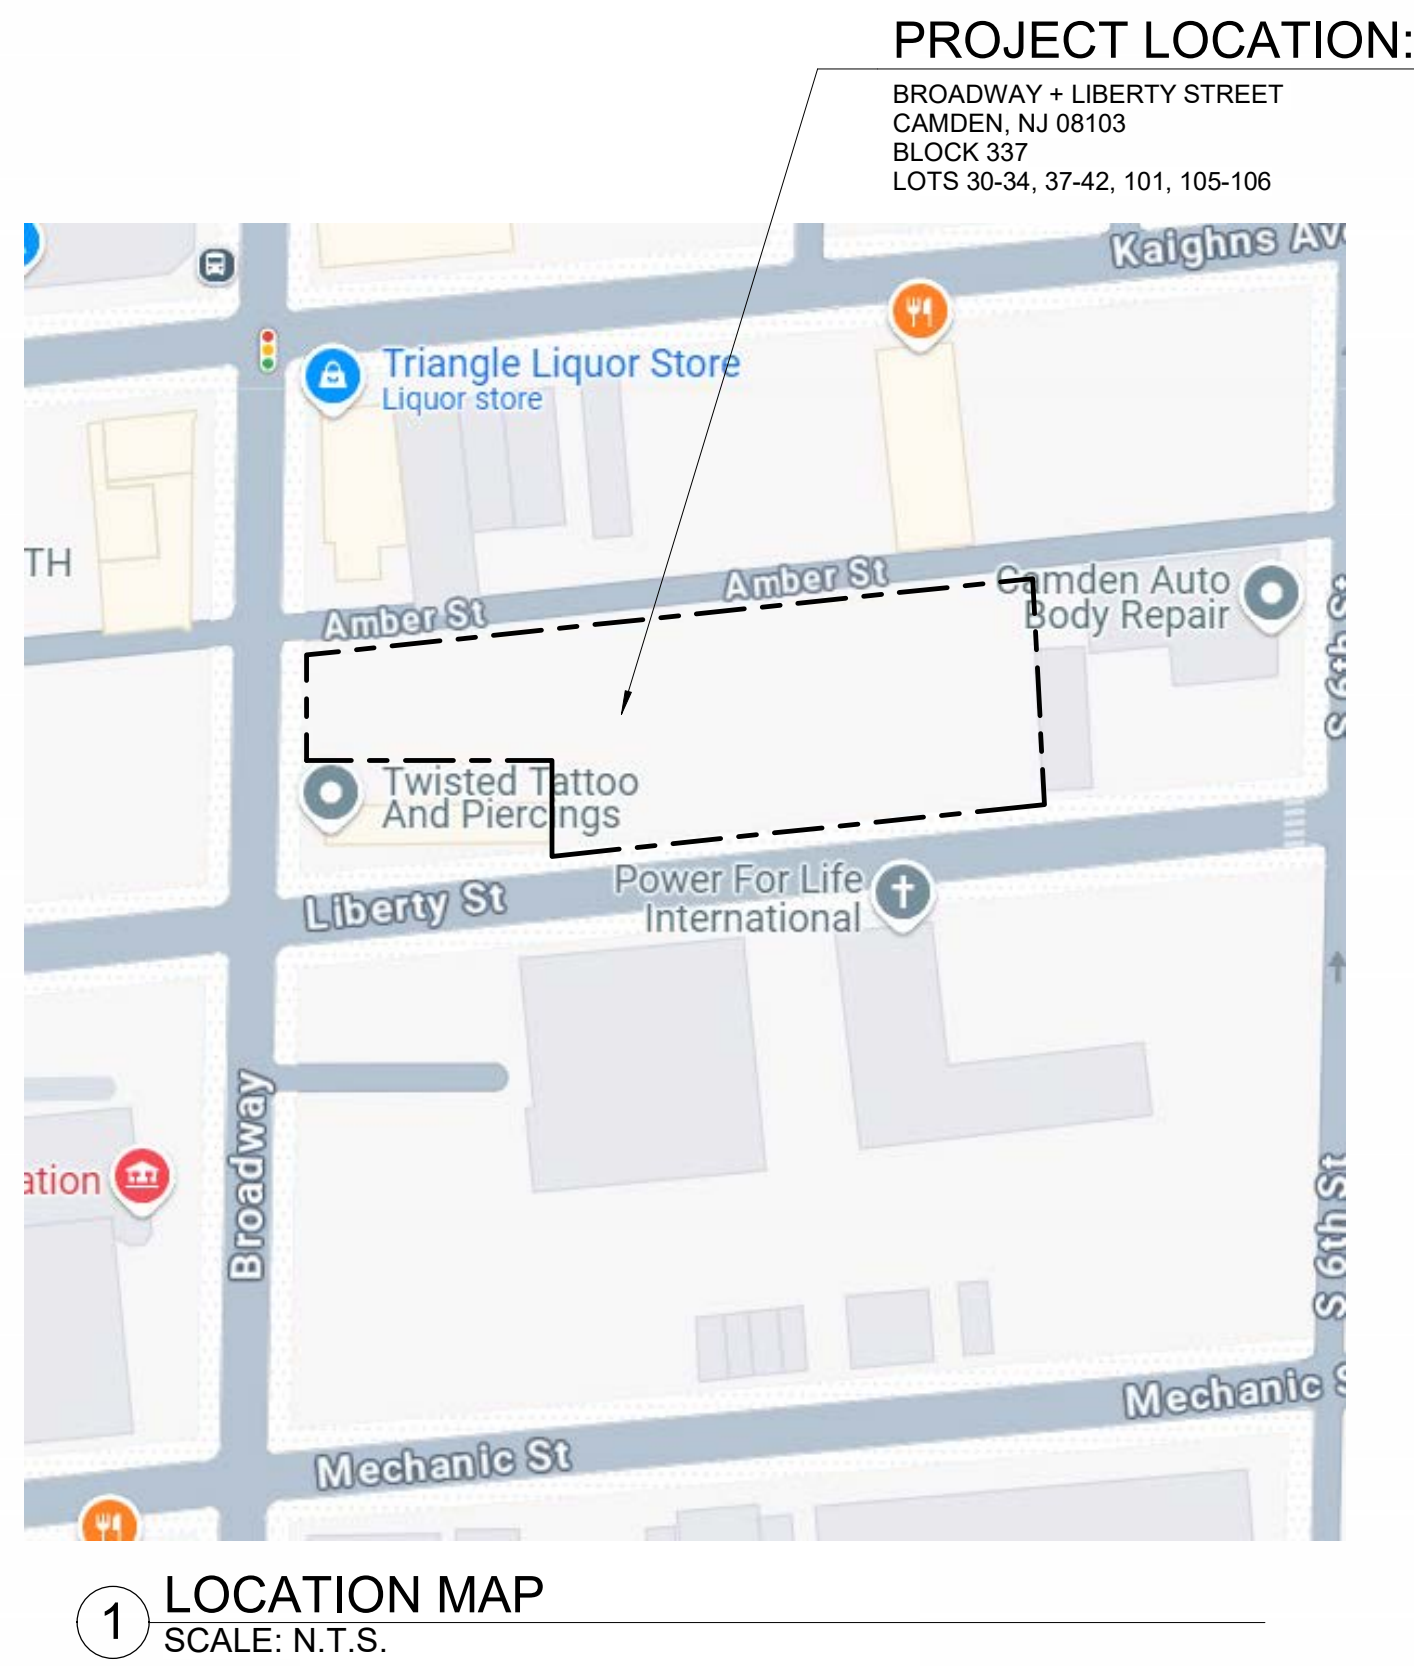

PROJECT VIEW



2 BUILDING ENTRANCE CONCEPT VIEW
SCALE:

DRAWING LIST

GENERAL

A-000 TITLE SHEET

CIVIL

C0001 COVER SHEET
C0002 INFORMATION SHEET
C1801 EXISTING CONDITIONS PLAN
D0101 DEMOLITION PLAN
C0100 OVERALL SITE PLAN
C0101 DETAILED SITE PLAN
C0301 GRADING PLAN
C0401 UTILITY PLAN
C0501 LANDSCAPE AND LIGHTING PLAN
C0500 LANDSCAPE AND LIGHTING DETAIL SHEET
C1101 SITE DETAIL SHEET
C1102 SITE DETAIL SHEET
C1103 SITE DETAIL SHEET
C1104 STORM SEWER DETAIL SHEET
C1105 SANITARY SEWER DETAIL SHEET
C1106 WATER MAIN DETAIL SHEET
C1107 SOIL LOG DETAIL SHEET
C1201 SOIL EROSION & SEDIMENT CONTROL PLAN
C1202 SOIL COMPACTION PLAN
C1301 SOIL EROSION & SEDIMENT CONTROL NARRATIVE SHEET
C1302 SOIL EROSION & SEDIMENT CONTROL DETAIL SHEET

ARCHITECTURAL

A-001 GENERAL NOTES + BARRIER FREE LEGEND
A-002 PARTITION TYPE SCHEDULE + DETAILS
A-010 BUILDING CODE ANALYSIS - NEW JERSEY
A-011 FIRST FLOOR LIFE SAFETY + EGRESS PLAN
A-101 FIRST FLOOR CONSTRUCTION PLAN
A-140 ROOF PLAN
A-145 ROOF DETAILS
A-146 ROOF DETAILS
A-160 ENLARGED PLANS
A-165 ENLARGED TOILET + SHOWER PLANS AND DETAILS
A-166 ENLARGED TOILET PLANS AND DETAILS
A-180 PLAN DETAILS
A-181 PLAN DETAILS
A-182 PLAN DETAILS
A-201 FIRST FLOOR REFLECTED CEILING PLAN
A-300 EXTERIOR ELEVATIONS
A-400 BUILDING SECTIONS
A-430 WALL SECTIONS
A-431 WALL SECTIONS
A-432 WALL SECTIONS
A-433 WALL SECTIONS
A-434 WALL SECTIONS
A-435 WALL SECTIONS
A-436 WALL SECTIONS
A-440 SECTION DETAILS
A-441 SECTION DETAILS
A-500 STAIR + RAMP - ENLARGED PLANS, SECTIONS AND DETAILS
A-600 DOOR - SCHEDULES + DETAILS
A-601 EXTERIOR DOOR DETAILS
A-610 WINDOW ELEVATIONS
A-650 WINDOW DETAILS
A-710 INTERIOR ELEVATIONS
A-730 CASEWORK ELEVATIONS
A-750 CASEWORK DETAILS
A-800 FINISH PLAN, SCHEDULE, NOTES + FINISH TRANSITIONS
A-801 FIRST FLOOR FINISH PLAN
A-851 FIRST FLOOR FURNITURE PLAN

FOOD SERVICE

FS-1 FOOD SERVICE EQUIPMENT PLAN
FS-2 FOOD SERVICE EQUIPMENT SCHEDULE + NOTES
FS-3 FOOD SERVICE PLUMBING CONN. PLAN
FS-4 FOOD SERVICE ELECTRICAL CONN. PLAN
FS-5 FOOD SERVICE SPECIAL CONDITIONS PLAN

STRUCTURAL

S-001 GENERAL NOTES I
S-002 GENERAL NOTES II
S-100 FOUNDATION PLAN
S-101 MAIN ROOF FRAMING PLAN
S-102 HIGH ROOF FRAMING PLAN
S-103 BRACED BAY ELEVATION AND DETAILS
S-201 SECTIONS
S-300 TYPICAL DETAILS I
S-301 TYPICAL DETAILS II

FIRE PROTECTION

FP-001 GENERAL NOTES & SYMBOL LIST
FP-100 FIRST FLOOR PLAN - FIRE PROTECTION
FP-500 DETAILS & SCHEDULES

PLUMBING

P-001 GENERAL NOTES & SYMBOL LIST
P-100 FIRST FLOOR AND ROOF PLANS -
SANITARY/VENT/STORM
P-200 FIRST FLOOR PLAN - DOMESTIC WATER/GAS
P-500 DETAILS & SCHEDULES
P-600 DETAILS & SCHEDULES

MECHANICAL

M-001 GENERAL NOTES & SYMBOL LIST
M-100 FIRST FLOOR AND ROOF PLANS - MECHANICAL
M-500 DETAILS
M-501 DETAILS
M-600 SCHEDULES

ELECTRICAL

E-001 GENERAL NOTES & SYMBOL LIST
E-010 SITE PLAN AND DETAILS - ELECTRIC
E-100 FIRST FLOOR PLAN - POWER
E-101 ROOF PLAN - POWER
E-200 FIRST FLOOR CEILING PLAN - LIGHTING
E-500 DETAILS
E-501 DETAILS
E-600 SCHEDULES


BUILDING DATA + INFORMATION

SUMMARY:
USE GROUP(S): B + A-3
CONSTRUCTION TYPE: IIB
SPRINKLERED: Y
BUILDING AREA: 8,125 SF
MAXIMUM HEIGHT: 1 STORIES 20 FEET
BUILDING VOLUME: 130,400 CU FT
OVERALL OCCUPANT LOAD: 170

ABBREVIATIONS

A.F.F.	ABOVE FINISHED FLOOR	HP	HIGH POINT
ALT.	ALTERNATE	HR.	HOUR
ALUM.	ALUMINUM	IN.	INCH
&	AND	INSUL.	INSULATION
@	ACOUSTICAL PANEL CEILING	INT.	INTERIOR
APC	AT	JOINT	JOINT
BLDG.	BUILDING	LP	LOW POINT
B.O.	BOTTOM OF	MAX.	MAXIMUM
C.J.	CONTROL JOINT	MIN.	MINIMUM OR MINUTES
C	CENTERLINE	MISC.	MISCELLANEOUS
CMU	CONCRETE MASONRY UNIT	M.O.	MASONRY OPENING
CONC.	CONCRETE	N.I.C.	NOT IN CONTRACT
CU	CUBIC	N.T.S.	NOT TO SCALE
DIA. OR Ø	DIAMETER	O.C.	ON CENTER
DN.	DIMENSION(S)	OH	OVERHEAD
DWG(S)	DRAWING(S)	OPP. HD.	OPPOSITE HAND
EA	EACH	PT	PRESSURE TREATED
E.I.F.S.	EXTERIOR INSULATION & FINISH SYSTEM	R.D.	ROOF DRAIN
E.J.	EQUAL	REINF.	REINFORCE(MENT) OR REINFORCING
EQ.	EQUIPMENT	REQ'D	REQUIRED
EQUIP.	EXISTING TO REMAIN	R.O.	ROUGH OPENING
E.T.R.	EXISTING	RM.	SIMILAR
EXT.	EXTERIOR	SF	SPECIFICATIONS
F.D.	FLOOR DRAIN	SQ.	SQUARE FOOT
FEET OR FOOT	FEET OR FOOT	SQ.	SQUARE
F.E.	FIRE EXTINGUISHER	S.S.	STAINLESS STEEL
F.E.C.	FIRE EXTINGUISHER CABINET	TEMP.	TEMPORARY
GA.	FINISH OR FINISHED	T.O.	TOP OF
GALV.	GALVANIZED	TYP.	TYPICAL
GYP.	GYPSUM	U.O.N.	UNLESS OTHERWISE NOTED
HT.	HOLLOW METAL	VERT.	VERTICAL
HORIZ.	HORIZONTAL	V.I.F.	VERY IN FIELD
		WD	WOOD
		W/	WITH
		W/O	WITHOUT
		W.W.M.	WELDED WIRE MESH
		YD.	YARD

SYMBOL LEGEND

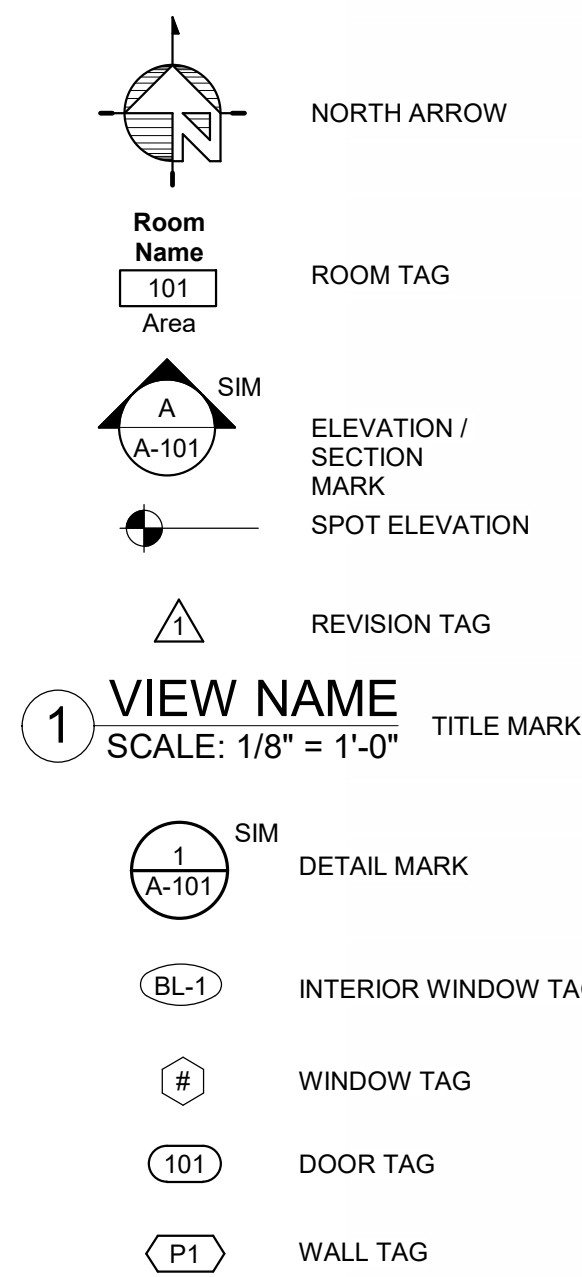

DESIGN TEAM

ARCHITECT
USA
Architects
USA ARCHITECTS, PLANNERS AND
INTERIOR DESIGNERS, LTD.
20 NORTH DOUGHTY AVENUE
SOMERVILLE, NJ 07016
908.722.2300
CONTACT: MARLENE BORRUSO

STRUCTURAL
MPP
MPP ENGINEERS, LLC
34 S MAIN ST
ALLEN TOWN, NJ 08501
609.489.5511
CONTACT: SCOTT MCCONNELL

CIVIL
MARATHON
Engineering & Environmental Services
MARATHON ENGINEERING
& ENVIRONMENTAL SERVICES
3 KILLDEER COURT, SUITE 302
SWEDESBO, NJ 08085
856.241.9705
CONTACT: DAVID DOMEN

**MECHANICAL, ELECTRICAL,
PLUMBING & FIRE PROTECTION**
sae
strunk-albert engineering
STRUNK-ALBERT ENGINEERING
804 SEVEN BRIDGE RD
EAST STROUDSBURG, PA 18301
570.421.2025
CONTACT: JARED FERRI

FOOD SERVICE
RAYMOND/RAYMOND ASSOCIATES
FOOD SERVICE CONSULTANTS SERVICES 1898
RAYMOND/RAYMOND ASSOCIATES
FOODSERVICE DESIGN CONSULTANTS
44 ST. JOHN ST
GOSHEN, NY 10924
845.360.5112
CONTACT: BRETT FARRELL

Susan M. DeHart, AIA

Registered Architect - New Jersey License No. A118243
USA Architects, Planners and Interior Designers, LTD.
NJ: 21AC00116500 PA: A00016502 DE: 57-000564 MD: 17644
This Document is the property and copyright of USA Architects for the
specified project and shall not be used or reproduced without
authorization.

NEW CONSTRUCTION

OF

MULTI-AGENCY CENTER

FOR

CAMDEN COUNTY

PROJECT ADDRESS:

BROADWAY AND LIBERTY STREET

CAMDEN, NEW JERSEY

8/26/25 ISSUED FOR PERMIT
No. Date Issue or Revision


Drawing Title

TITLE SHEET

Scale As indicated USA Project No. R2024.0082.00

Drawing Date 05.16.2025 Drawing No.

Drawn By PO Checked By TJC A-000

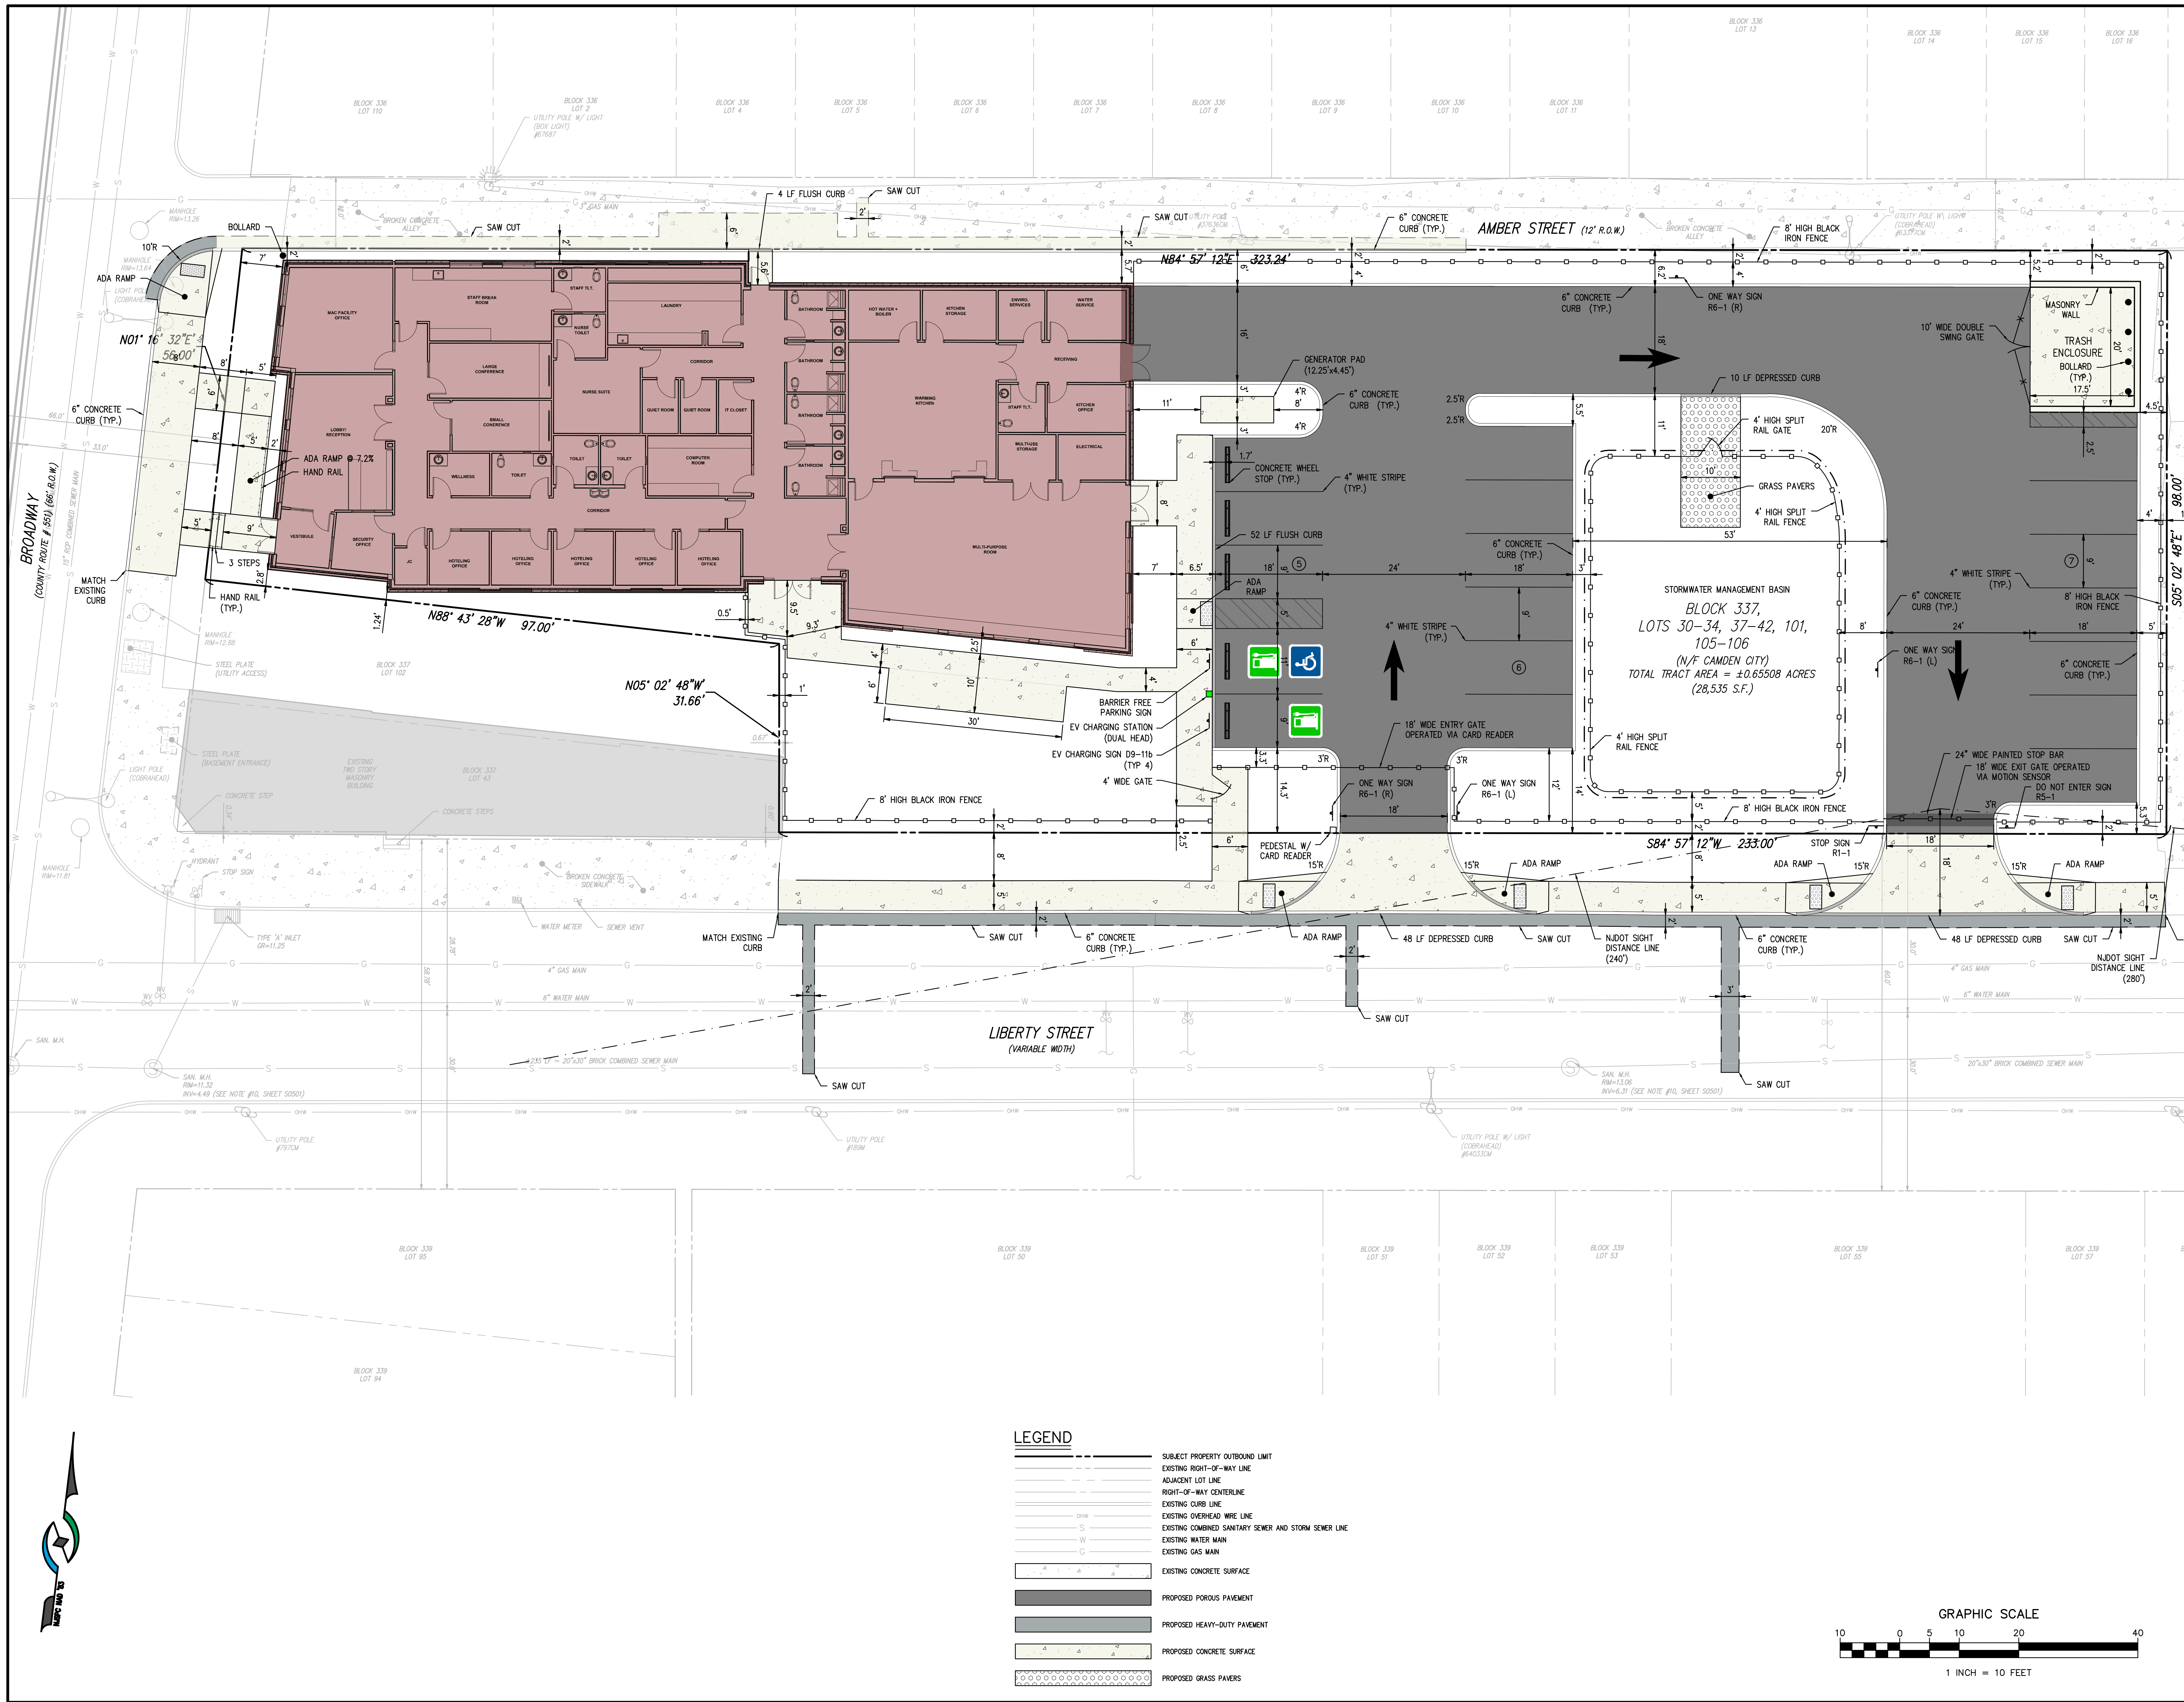

20 N. Doughty Avenue
Somerville, NJ 08876
t 908.722.2300
f 908.722.7201

usaarchitects.com

Paul R. Swartz, AIA
Armand T. Christopher Jr., AIA
Peter C. Campesano, AIA

Susan M. Delight, AIA
James McLaughlin, AIA
Eric DeLong, AIA



08/26/2025
DAVID J. FLEMING, P.E.
NEW JERSEY LICENSE NO. 24GE03321600

USA Architects, Planners and Interior Designers, LTD.
No. 21AC00161000 PA: A00016020, DE: S1000564 MD: 17644
This Document is the property and copyright of USA Architects for the
specified project and shall not be used or reproduced without
authorization.

NEW CONSTRUCTION
OF
MULTI-AGENCY CENTER
FOR
CAMDEN COUNTY
BROADWAY AND LIBERTY STREET
CAMDEN, NEW JERSEY

1 08.26.25 ISSUED FOR PERMIT

No. Date Issue or Revision

Drawing Title

DETAILED SITE PLAN

Scale

1" = 10'

Drawing Date

03.07.2025

Drawn By

DJD

USA Project No.

R2024.0082.00

Drawing No.

C0101

Checked By

DJF

LEGEND:

SYMBOL	DESCRIPTION	SYMBOL	DESCRIPTION
	STUD PARTITION		ELEVATION / SECTION MARK
	DOOR		INTERIOR ELEVATION
	ROOM TAG		DETAIL MARK
	WINDOW TAG		SPOT ELEVATION
	DOOR TAG		
	WALL TAG		
	REVISION TAG		

GENERAL NOTES:

- ALL INTERIOR WALL PARTITIONS TO BE TYPE 'A3' UNLESS OTHERWISE NOTED
- DIMENSIONS ARE FROM FACE OF STUD TO FACE OF STUD UNLESS OTHERWISE NOTED. GC TO NOTIFY ARCHITECT IMMEDIATELY IF DISCREPANCIES OCCUR FOR A FIELD RESOLUTION.
 - DIMENSIONS NOTED AS "HOLD" OR "CLEAR" INDICATE REQUIRED MINIMUM UNOBSTRUCTED DISTANCE FROM FINISH FACE TO FINISH FACE. DEVIATION WILL RESULT IN REJECTION OF WORK.
 - ALIGN FINISH FACE OF WALLS WITH FINISH FACE OF ADJACENT WALLS UNLESS OTHERWISE NOTED. SOME WALLS MAY REQUIRE FURRING OR STUDS AND GYPSUM BOARD IN ORDER TO MEET FINISH OR ALIGNMENT REQUIREMENTS.
 - ROOM AREAS, IF NOTED ON PLANS, REPRESENT NET ROOM SQUARE FOOTAGE.
 - SEE ENLARGED PLANS FOR ADDITIONAL DIMENSIONS, WALL AND DOOR TAGS, AND PARTITION TYPES.
 - SEE PARTITION TYPE SCHEDULE FOR INTERIOR PARTITION TYPE CONSTRUCTION DETAILS.
 - SEE FINISH PLANS AND FINISH SCHEDULE FOR FINISHES.
 - SEE FURNITURE AND EQUIPMENT PLANS FOR FURNITURE, EQUIPMENT, AND ACCESSORIES.
 - SEE REFLECTED CEILING PLANS FOR CEILING FINISHES AND HEIGHTS.
 - SEE ROOF PLAN AND DETAILS FOR ROOF INFORMATION.
 - SEE DOOR SCHEDULE FOR DOOR TYPES, ELEVATIONS, AND DETAILS. TYPICAL DOOR OFFSET SHALL BE 4". UNLESS OTHERWISE NOTED. CENTER ALL CLOSET DOORS WITHIN CLOSET, UNLESS OTHERWISE NOTED.
 - SEE SECTION DETAILS FOR TYPICAL BASE OF WALL AND FOUNDATION DETAILS.
 - SEE WINDOW ELEVATIONS FOR FRAMED WINDOW AND STOREFRONT TYPES AND DETAILS.
 - ALL STUD PARTITIONS THAT ARE INDICATED TO RECEIVE ACCESSORIES SUCH AS, BUT NOT LIMITED TO, TOILET ACCESSORIES, GRAB BARS, CASEWORK, WALL MOUNTED BACK-BOARDS, ETC. SHALL BE PROVIDED WITH SOLID FIRE RETARDANT TREATED (FRT) BLOCKING AND REINFORCEMENT WITHIN THE FRAMING TO ADEQUATELY SUPPORT THE INSTALLATION OF SUCH ITEMS. PROVIDE 3/4" FRT PLYWOOD BEHIND ELECTRIC PANELS AS INDICATED ON ELECTRICAL DRAWINGS.
 - PROVIDE CONTROL JOINTS IN GYPSUM BOARD FACES, TAPED AND SPACKLED SMOOTH AT ANY PARTITIONS GREATER THAN 50'. PROVIDE CONTROL JOINTS NOT MORE THAN 30'-0" APART.

SELECTIVE SCOPE OF WORK NOTES:

- ☒ CONSTRUCTION SCOPE OF WORK ITEM TYPICAL THROUGHOUT ENTIRE ROOM / AREA
- ☒ CONSTRUCTION SCOPE OF WORK ITEM AT A SPECIFIC LOCATION
- NOT USED
 - ROOF LADDER WITH 36" X 30" ROOF ACCESS HATCH ABOVE. REFER TO SPECIFICATION.
 - 5/8" F.R.T. PLYWOOD BACKER BOARD PANEL FROM FLOOR TO CEILING FOR MOUNTING OF ELECTRICAL/IT EQUIPMENT. SEE MEP DRAWINGS.
 - TRENCH FLOOR DRAIN - SEE MEP
 - WARMING KITCHEN EQUIPMENT - SEE FOODSERVICE DRAWINGS
 - EXTERIOR CONCRETE RAMP AND STAIR - SEE ENLARGED RAMP + STAIR PLAN AND CIVIL DRAWINGS




20 N. Doughty Avenue
Somerville, NJ 08876
t 908.722.2300
f 908.722.7201

usaarchitects.com

Paul R. Swartz, AIA
Armand T. Christopher Jr., AIA
Peter C. Campisano, AIA

Susan M. DeHart, AIA
James McAuffie, AIA
Eric DeLong, AIA

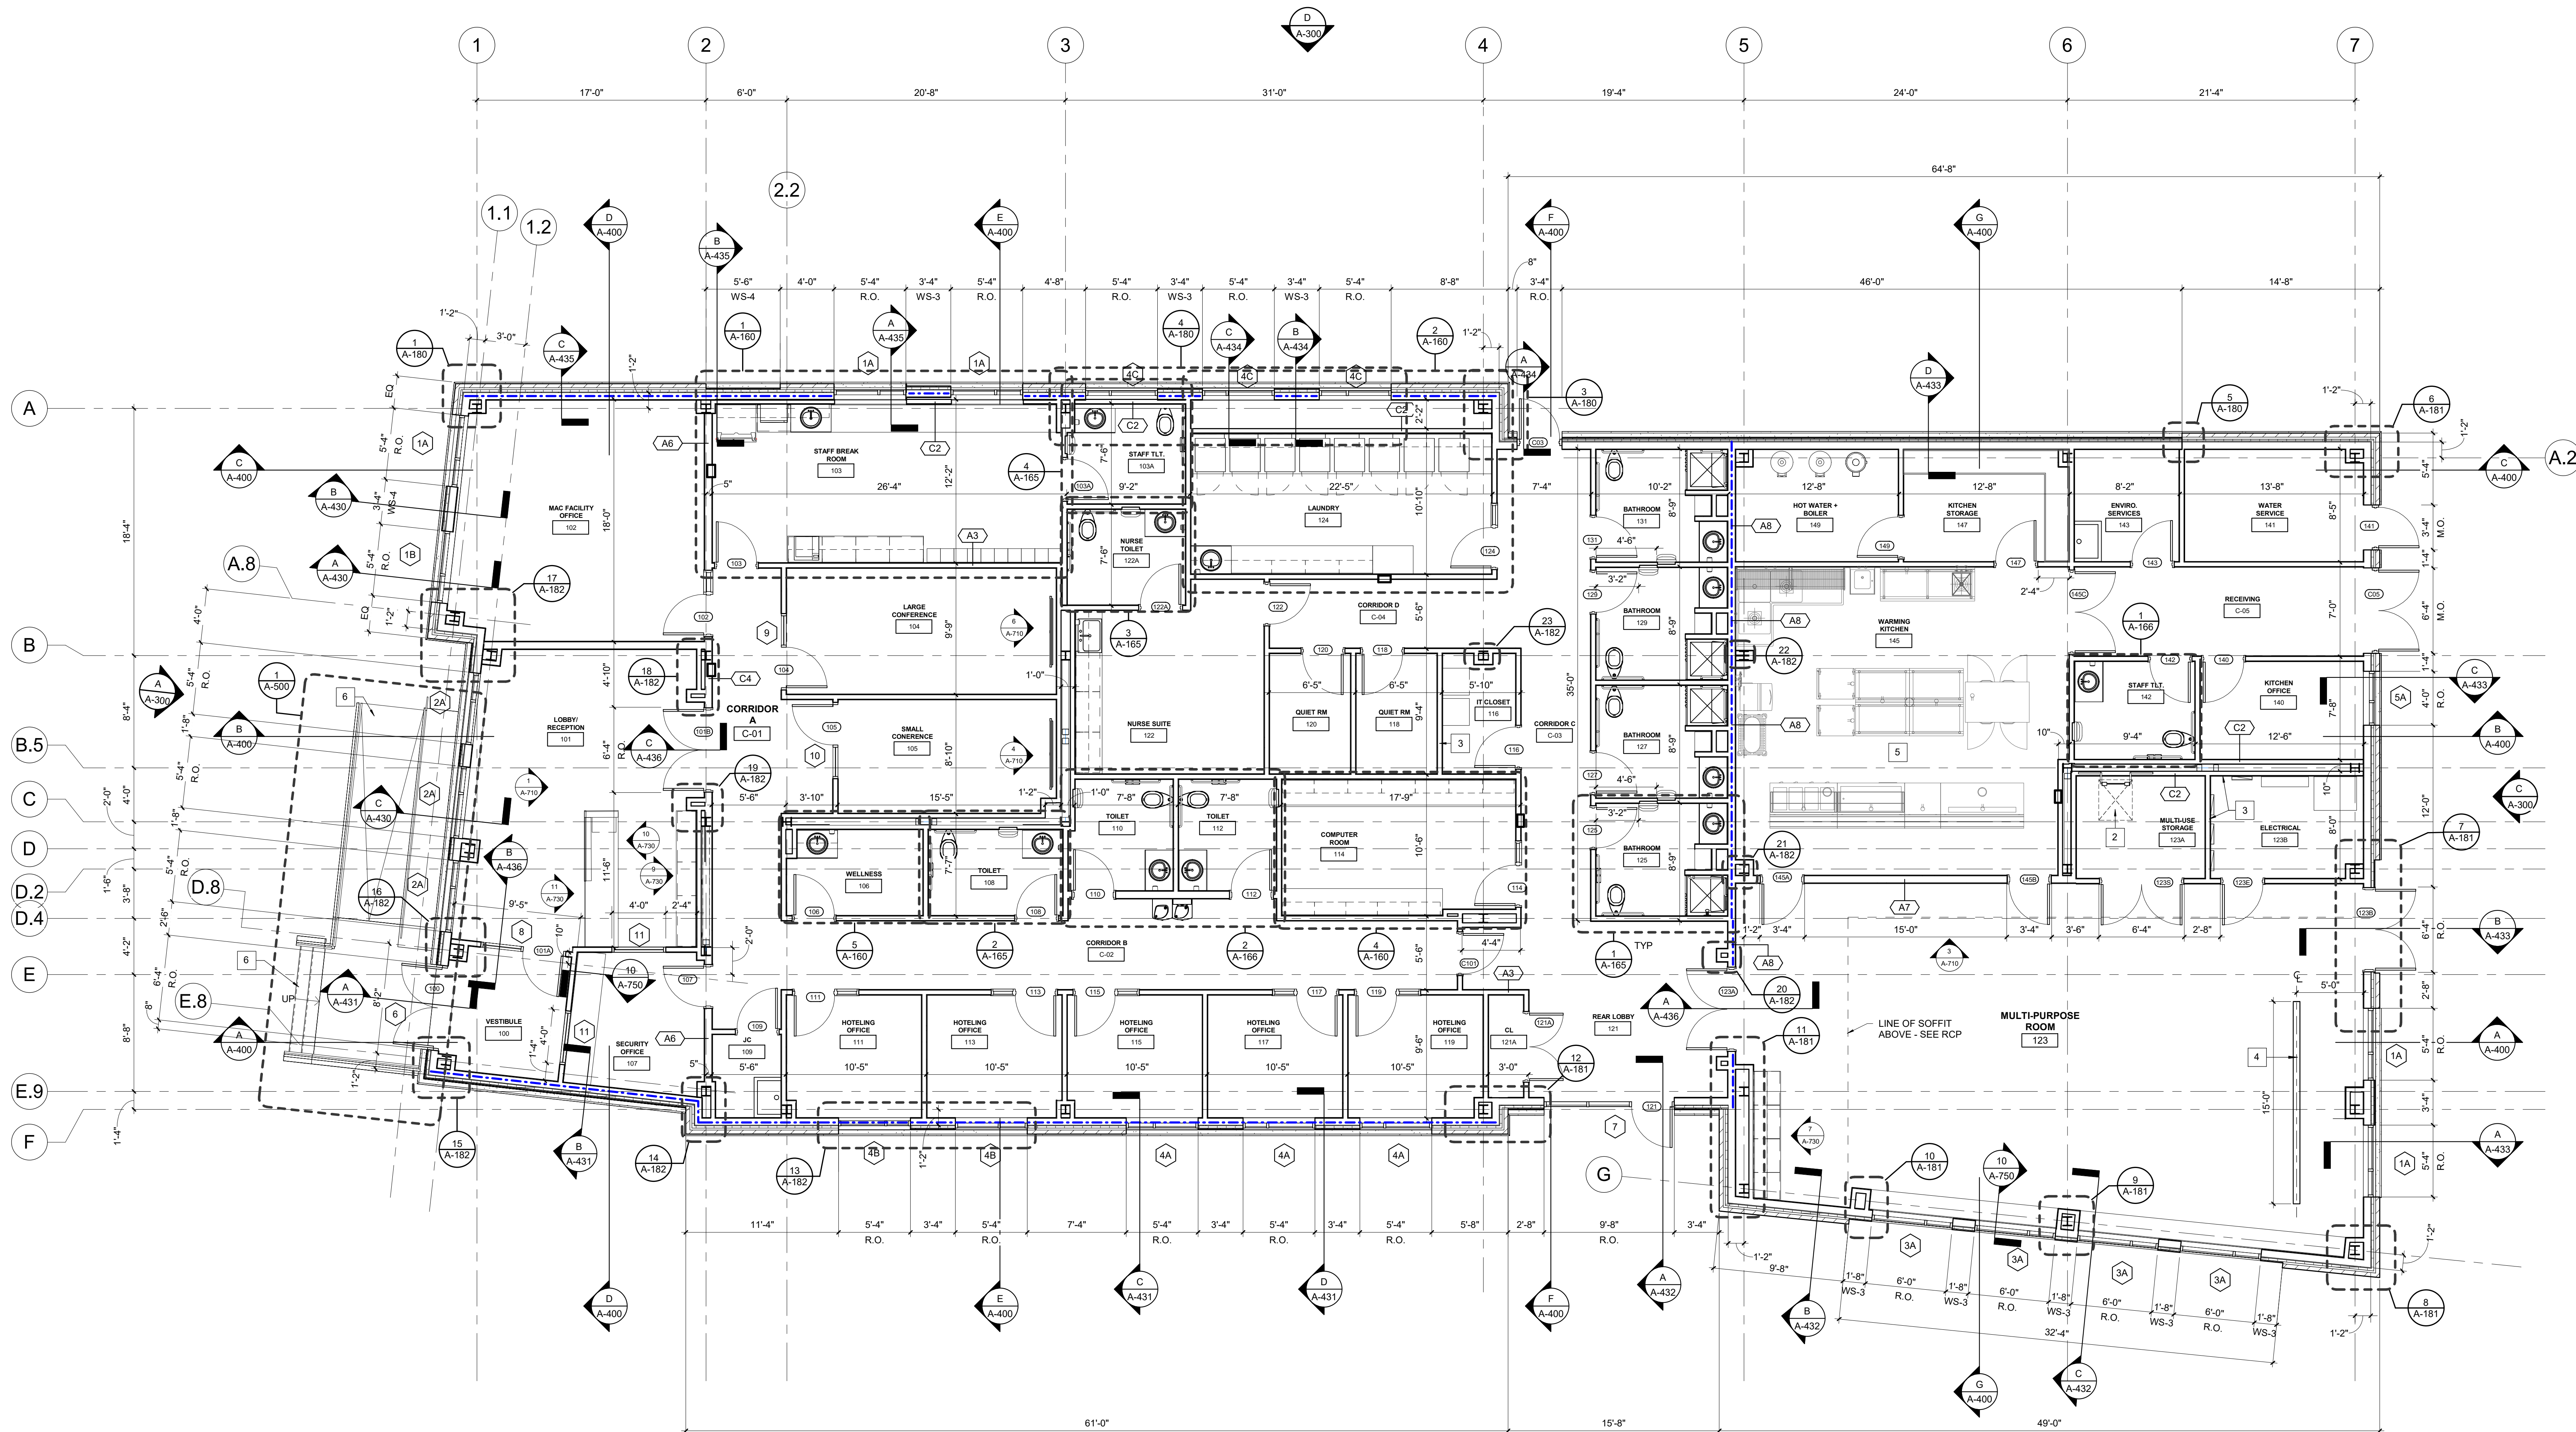

1 CONSTRUCTION FLOOR PLAN
SCALE: 3/16" = 1'-0"

Susan M. DeHart, AIA

Registered Architect - New Jersey License No. A118243

USA Architects, Planners and Interior Designers, LTD.
NJ: 21AC00116500 PA: A00016502 DE: 57-000564 MD: 17644
This Document is the property and copyright of USA Architects for the
specified project and shall not be used or reproduced without
authorization.

NEW CONSTRUCTION
OF
MULTI-AGENCY CENTER
FOR
CAMDEN COUNTY
PROJECT ADDRESS:
BROADWAY AND LIBERTY STREET
CAMDEN, NEW JERSEY

8.26.25 ISSUED FOR PERMIT
No. Date Issue or Revision

Drawing Title
FIRST FLOOR
CONSTRUCTION
PLAN

Scale
As indicated

USA Project No.
R2024.0082.00

Drawing Date
05.16.2025

Drawn By
PO

Checked By
TJC

A-101

